


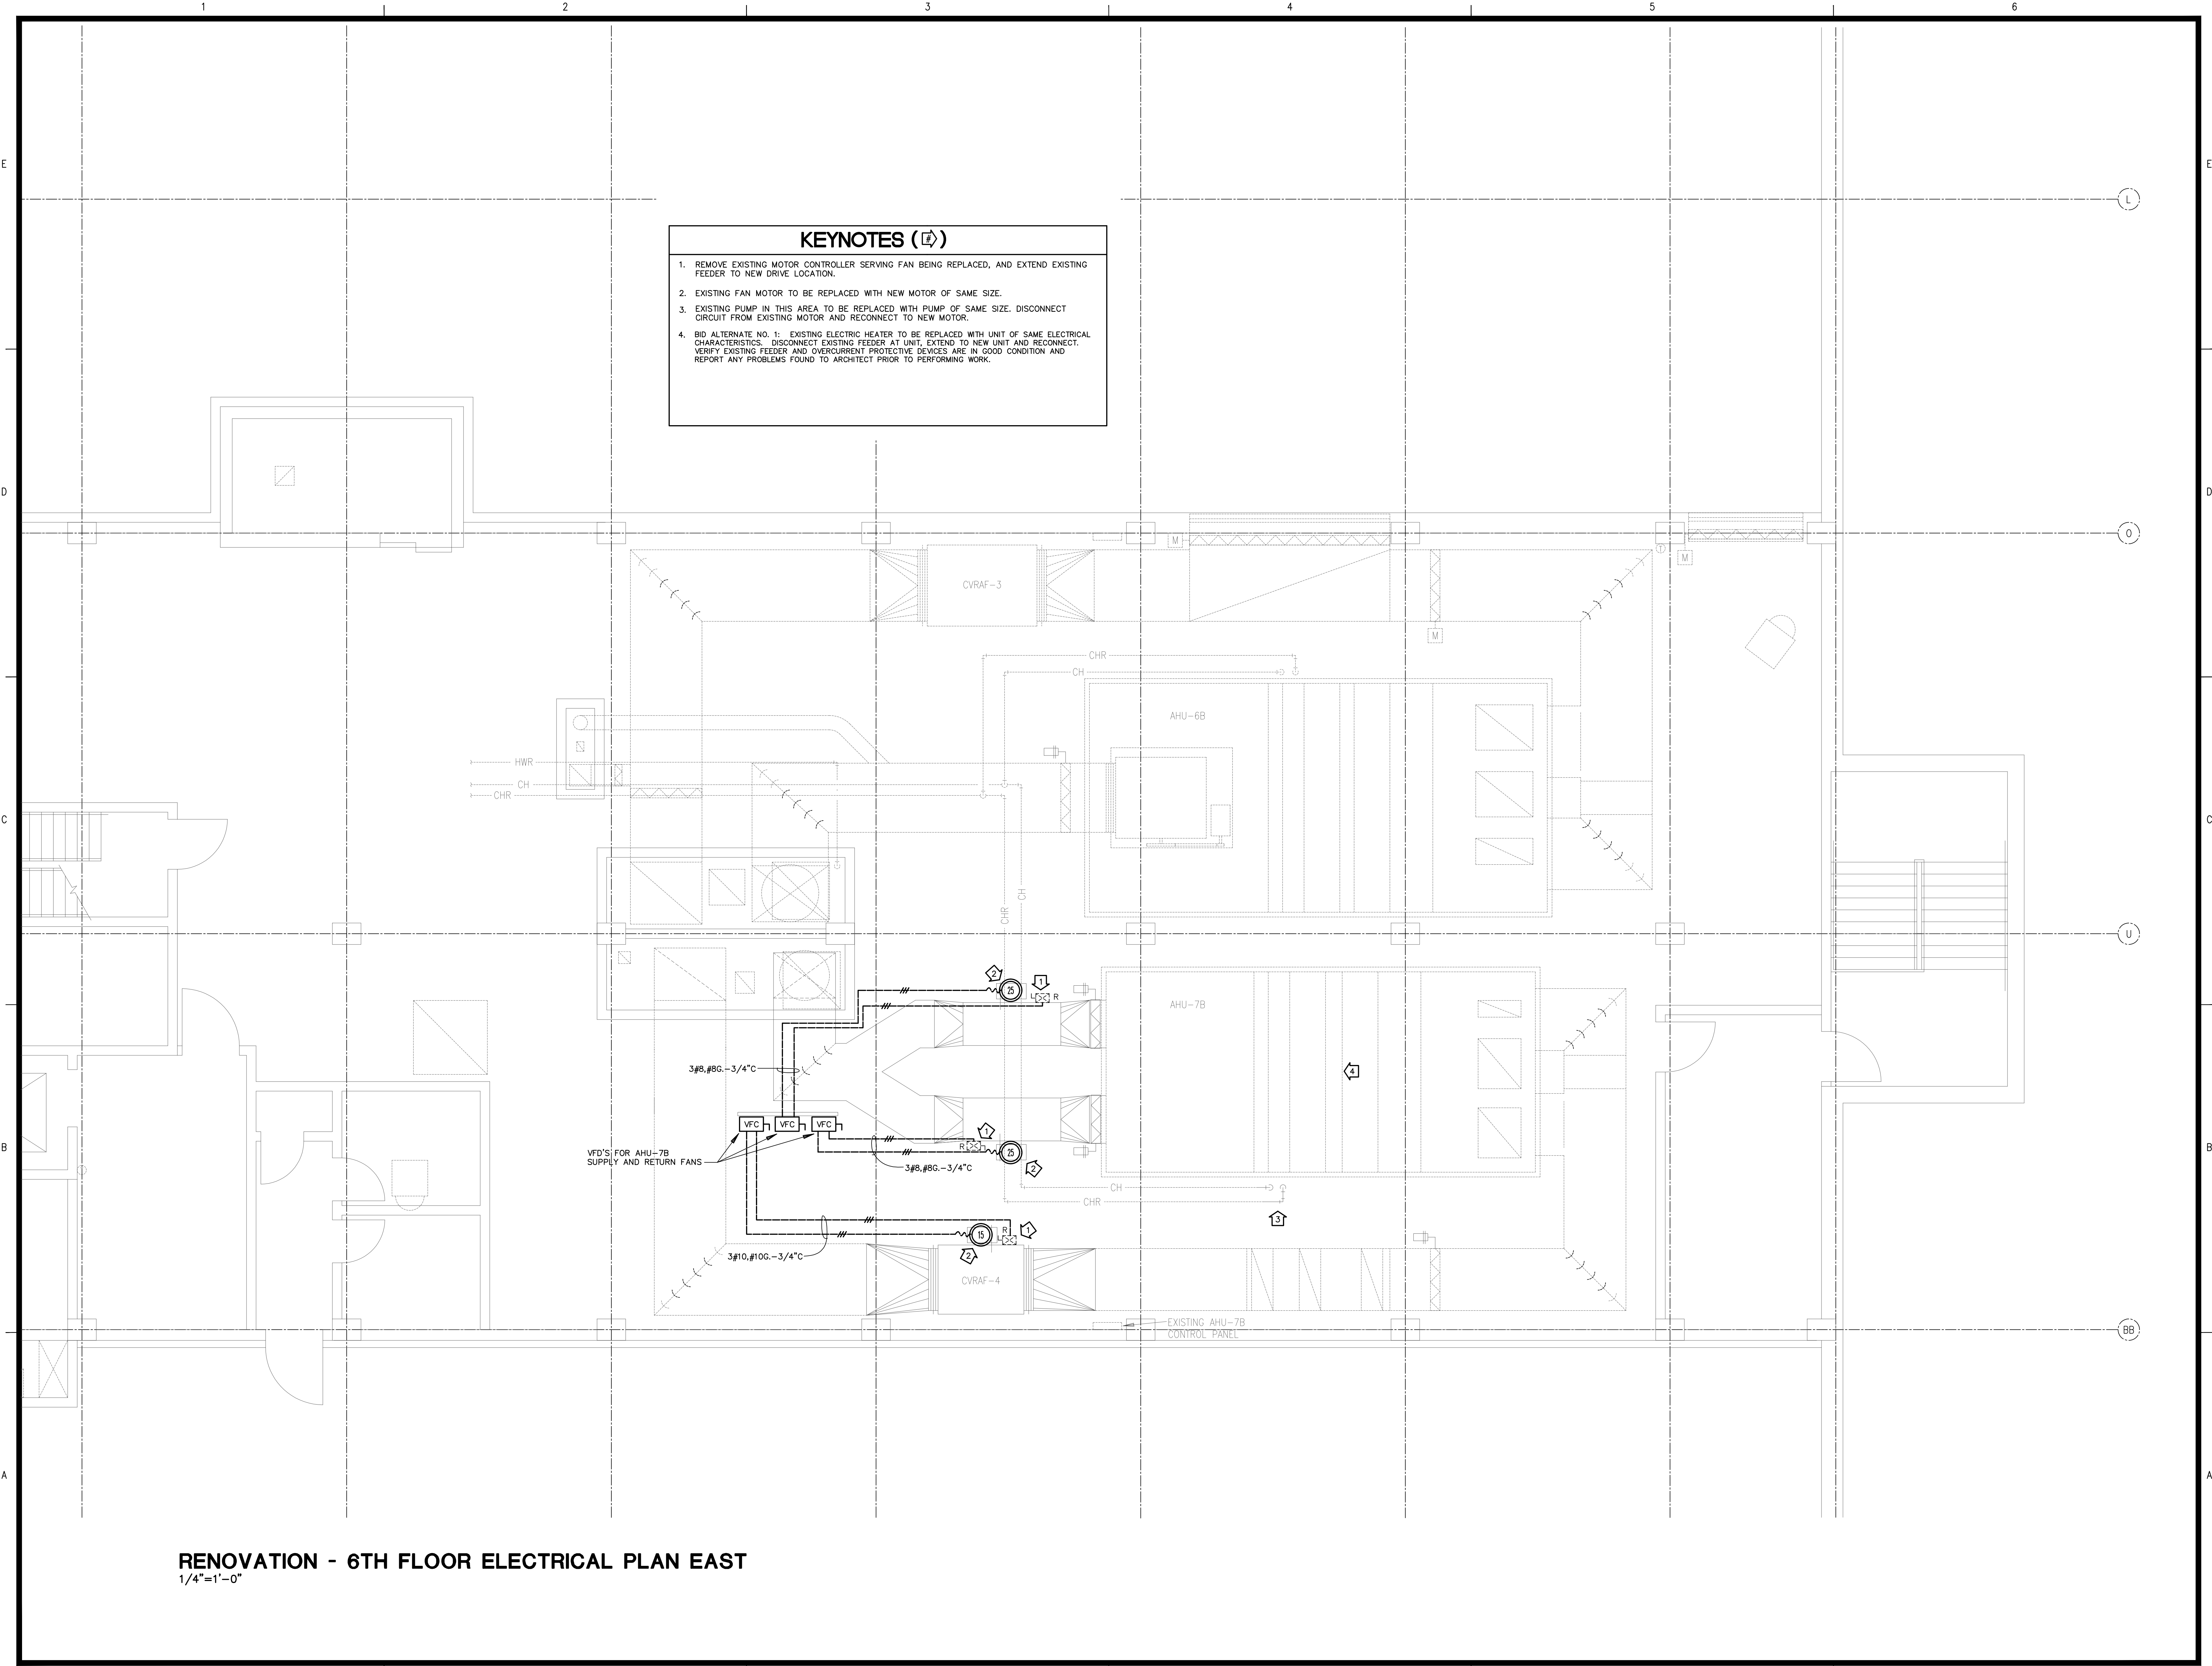

RENOVATION - 6TH FLOOR ELECTRICAL PLAN EAST
1/4"=1'-0"

REVISIONS:

PROJECT #:

24308.00

DATE:

JAN. 24, 2014

DRAWN BY:

CH

DESIGNER:

CH

CHECKED BY:

CH

Pickering

Pickering Firm, Inc.
Facility Design • Civil Engineering • Surveying •
Instrumentation • Water/Wastewater Resources
6775 Leach Center Court, Suite 300
Memphis, TN 38115
901.726.0810

OGCB

Incorporated

5485 Poplar Avenue, Suite 200
Memphis, TN 38117/901-452-8282

Mechanical/Electrical
Consulting Engineers

SBI-000242

HVAC RETROFIT PHASE I

SHELBY COUNTY CRIMINAL JUSTICE CENTER

201 POPLAR AVENUE

MEMPHIS, TENNESSEE 38103

SEAL:

CHARLES K. HODGSON

REGISTERED ENGINEER

12/23/14

STATE OF TENNESSEE

SHEET NUMBER:

E-131

DESCRIPTION:

RENOVATION - 6TH FLOOR
ELECTRICAL PLAN EAST

J:\131326 CJC HVAC Retrofit\131326.dwg, 1/23/2014 11:33:24 AM, aahr, 0.2512