


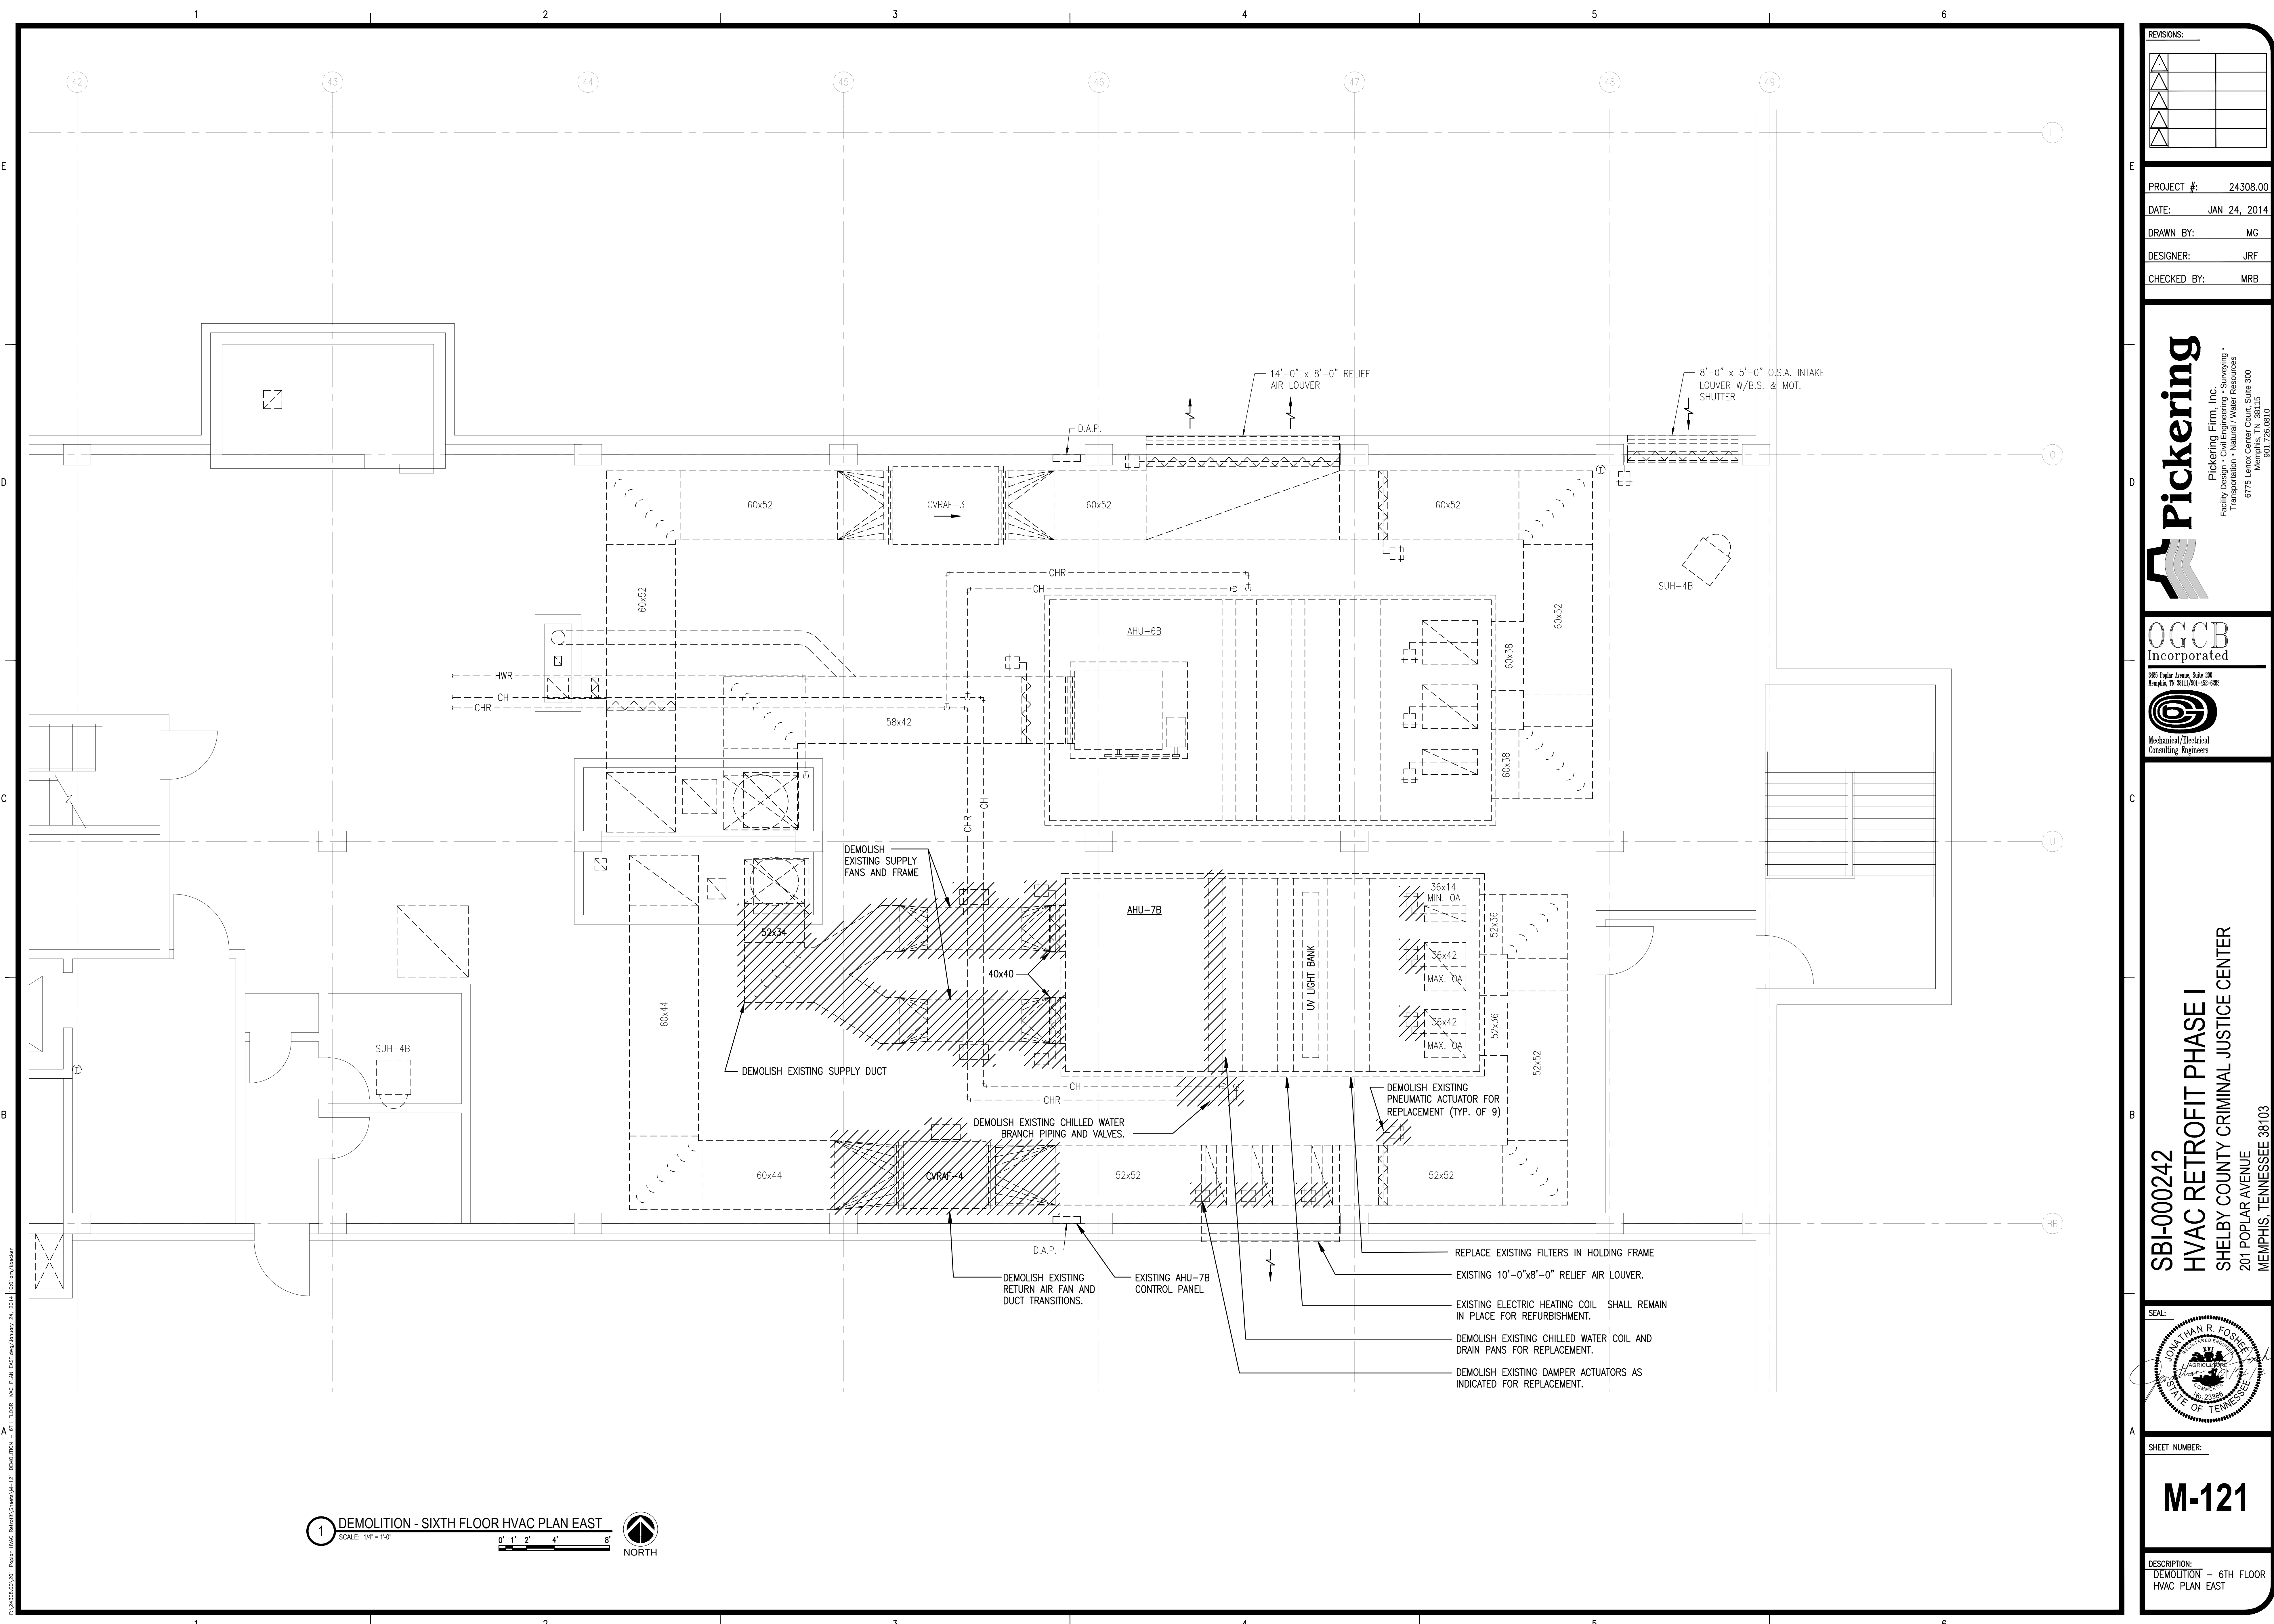

P:\3\3038\201201 Pickering HVAC Retrofit\Sheet\M-121 DEMOLITION - 6TH FLOOR HVAC PLAN EAST.dwg/January 24, 2014 10:01 am/Alviseo

REVISIONS:

PROJECT #:

24308.00

DATE:

JAN 24, 2014

DRAWN BY:

MG

DESIGNER:

JRF

CHECKED BY:

MRB

Pickering

Pickering Firm, Inc.
Civil • Mechanical • Electrical • Plumbing • Fire Protection • Energy • Surveying •
Transportation • Water • Waste Resources
6775 Levee Court, Suite 300
Memphis, TN 38115
901.726.0810

OGCB

Incorporated

395 Poplar Avenue, Suite 301
Memphis, TN 38102-6528
Mechanical/Electrical
Consulting Engineers

SBI-000242

HVAC RETROFIT PHASE I

SHELBY COUNTY CRIMINAL JUSTICE CENTER

201 POPLAR AVENUE

MEMPHIS, TENNESSEE 38103

SEAL:

JONATHAN R. FOSTER

REGISTERED PROFESSIONAL ENGINEER

MECHANICAL

NO. 23396

STATE OF TENNESSEE

SHEET NUMBER:

M-121

DESCRIPTION:

DEMOLITION - 6TH FLOOR
HVAC PLAN EAST