
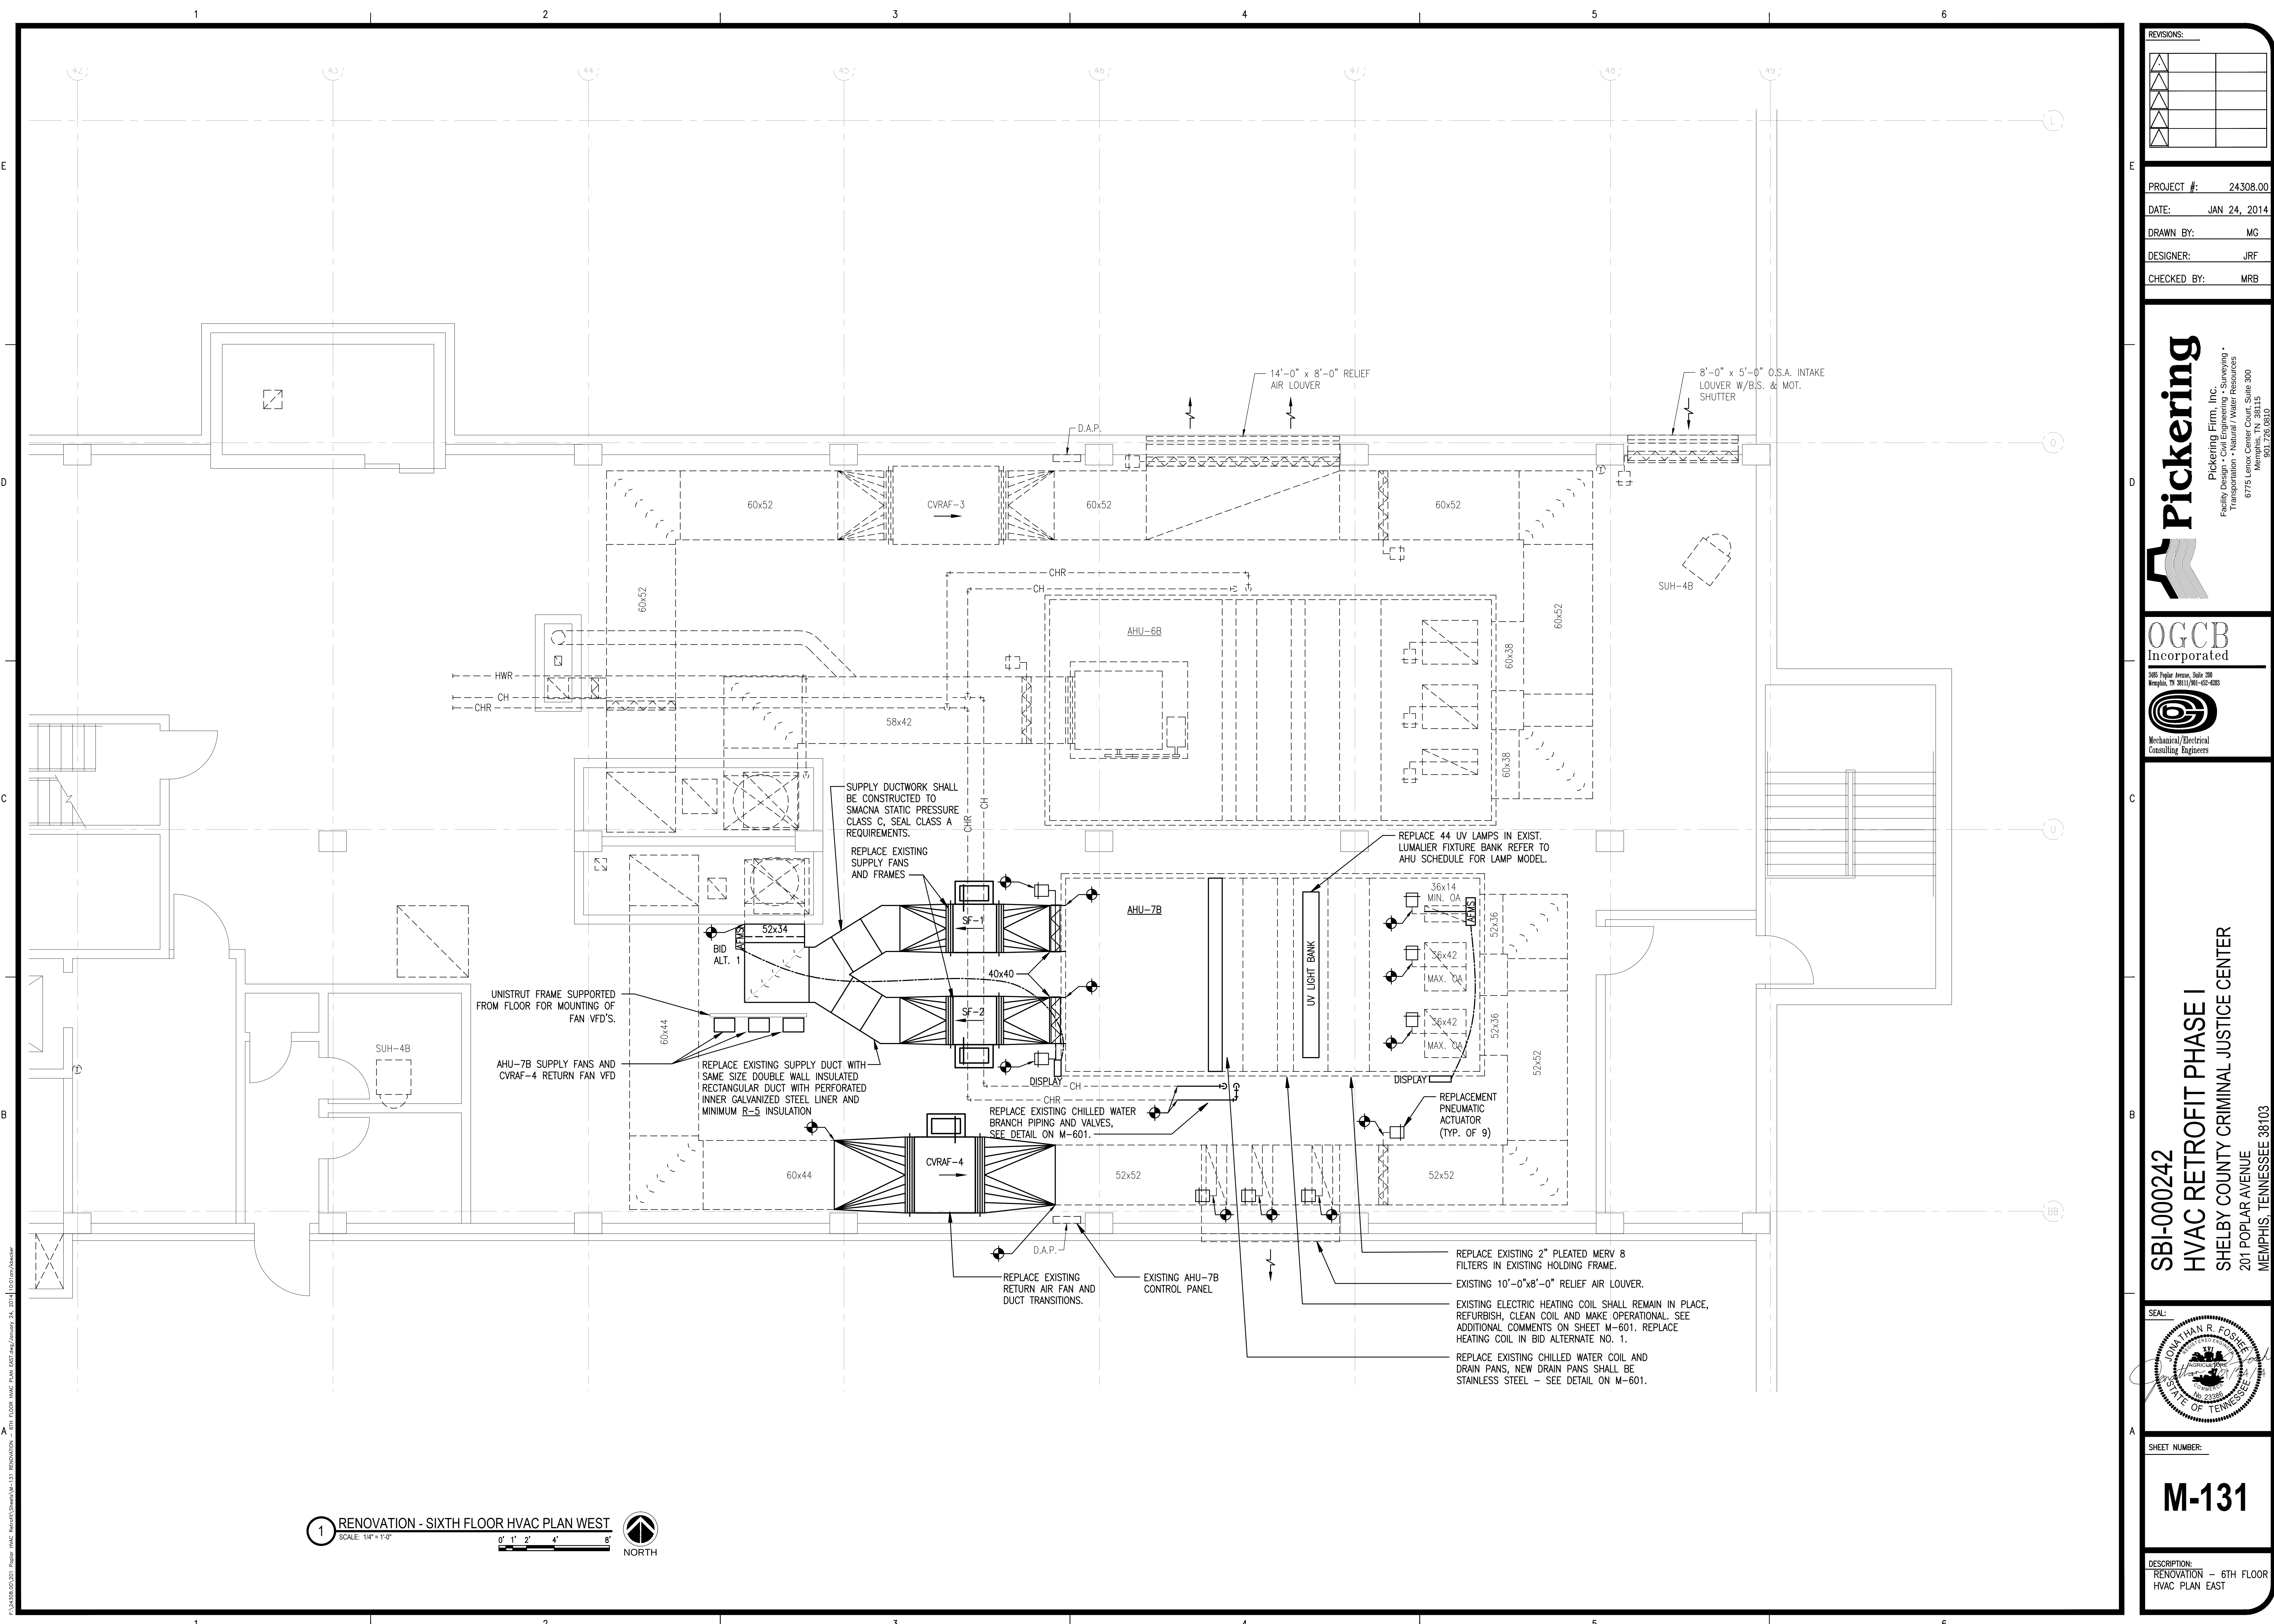


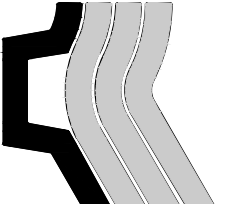

1 RENOVATION - SIXTH FLOOR HVAC PLAN WEST
SCALE: 1/4" = 1'-0"
NORTH

REVISIONS:		
▲		
▲		
▲		

PROJECT #: 24308.00
DATE: JAN 24, 2014
DRAWN BY: MG
DESIGNER: JRF
CHECKED BY: MRB

**Pickering**

Pickering Firm, Inc.
Facility Construction • Engineering • Surveying •
Transportation • Waste/Water Resources

6775 Levee Center Court, Suite 300
Memphis, TN 38115
901.726.0810


OGCB
Incorporated

595 Poplar Avenue, Suite 300
Memphis, TN 38101/901-652-6285


Mechanical/Electrical
Consulting Engineers

SBI-000242
HVAC RETROFIT PHASE I
SHELBY COUNTY CRIMINAL JUSTICE CENTER
201 POPLAR AVENUE
MEMPHIS, TENNESSEE 38103

SEAL:

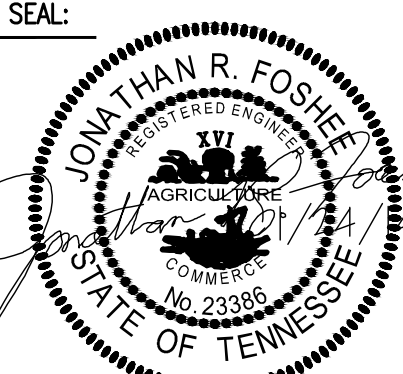

SHEET NUMBER:
M-131

DESCRIPTION:
RENOVATION - 6TH FLOOR
HVAC PLAN EAST